
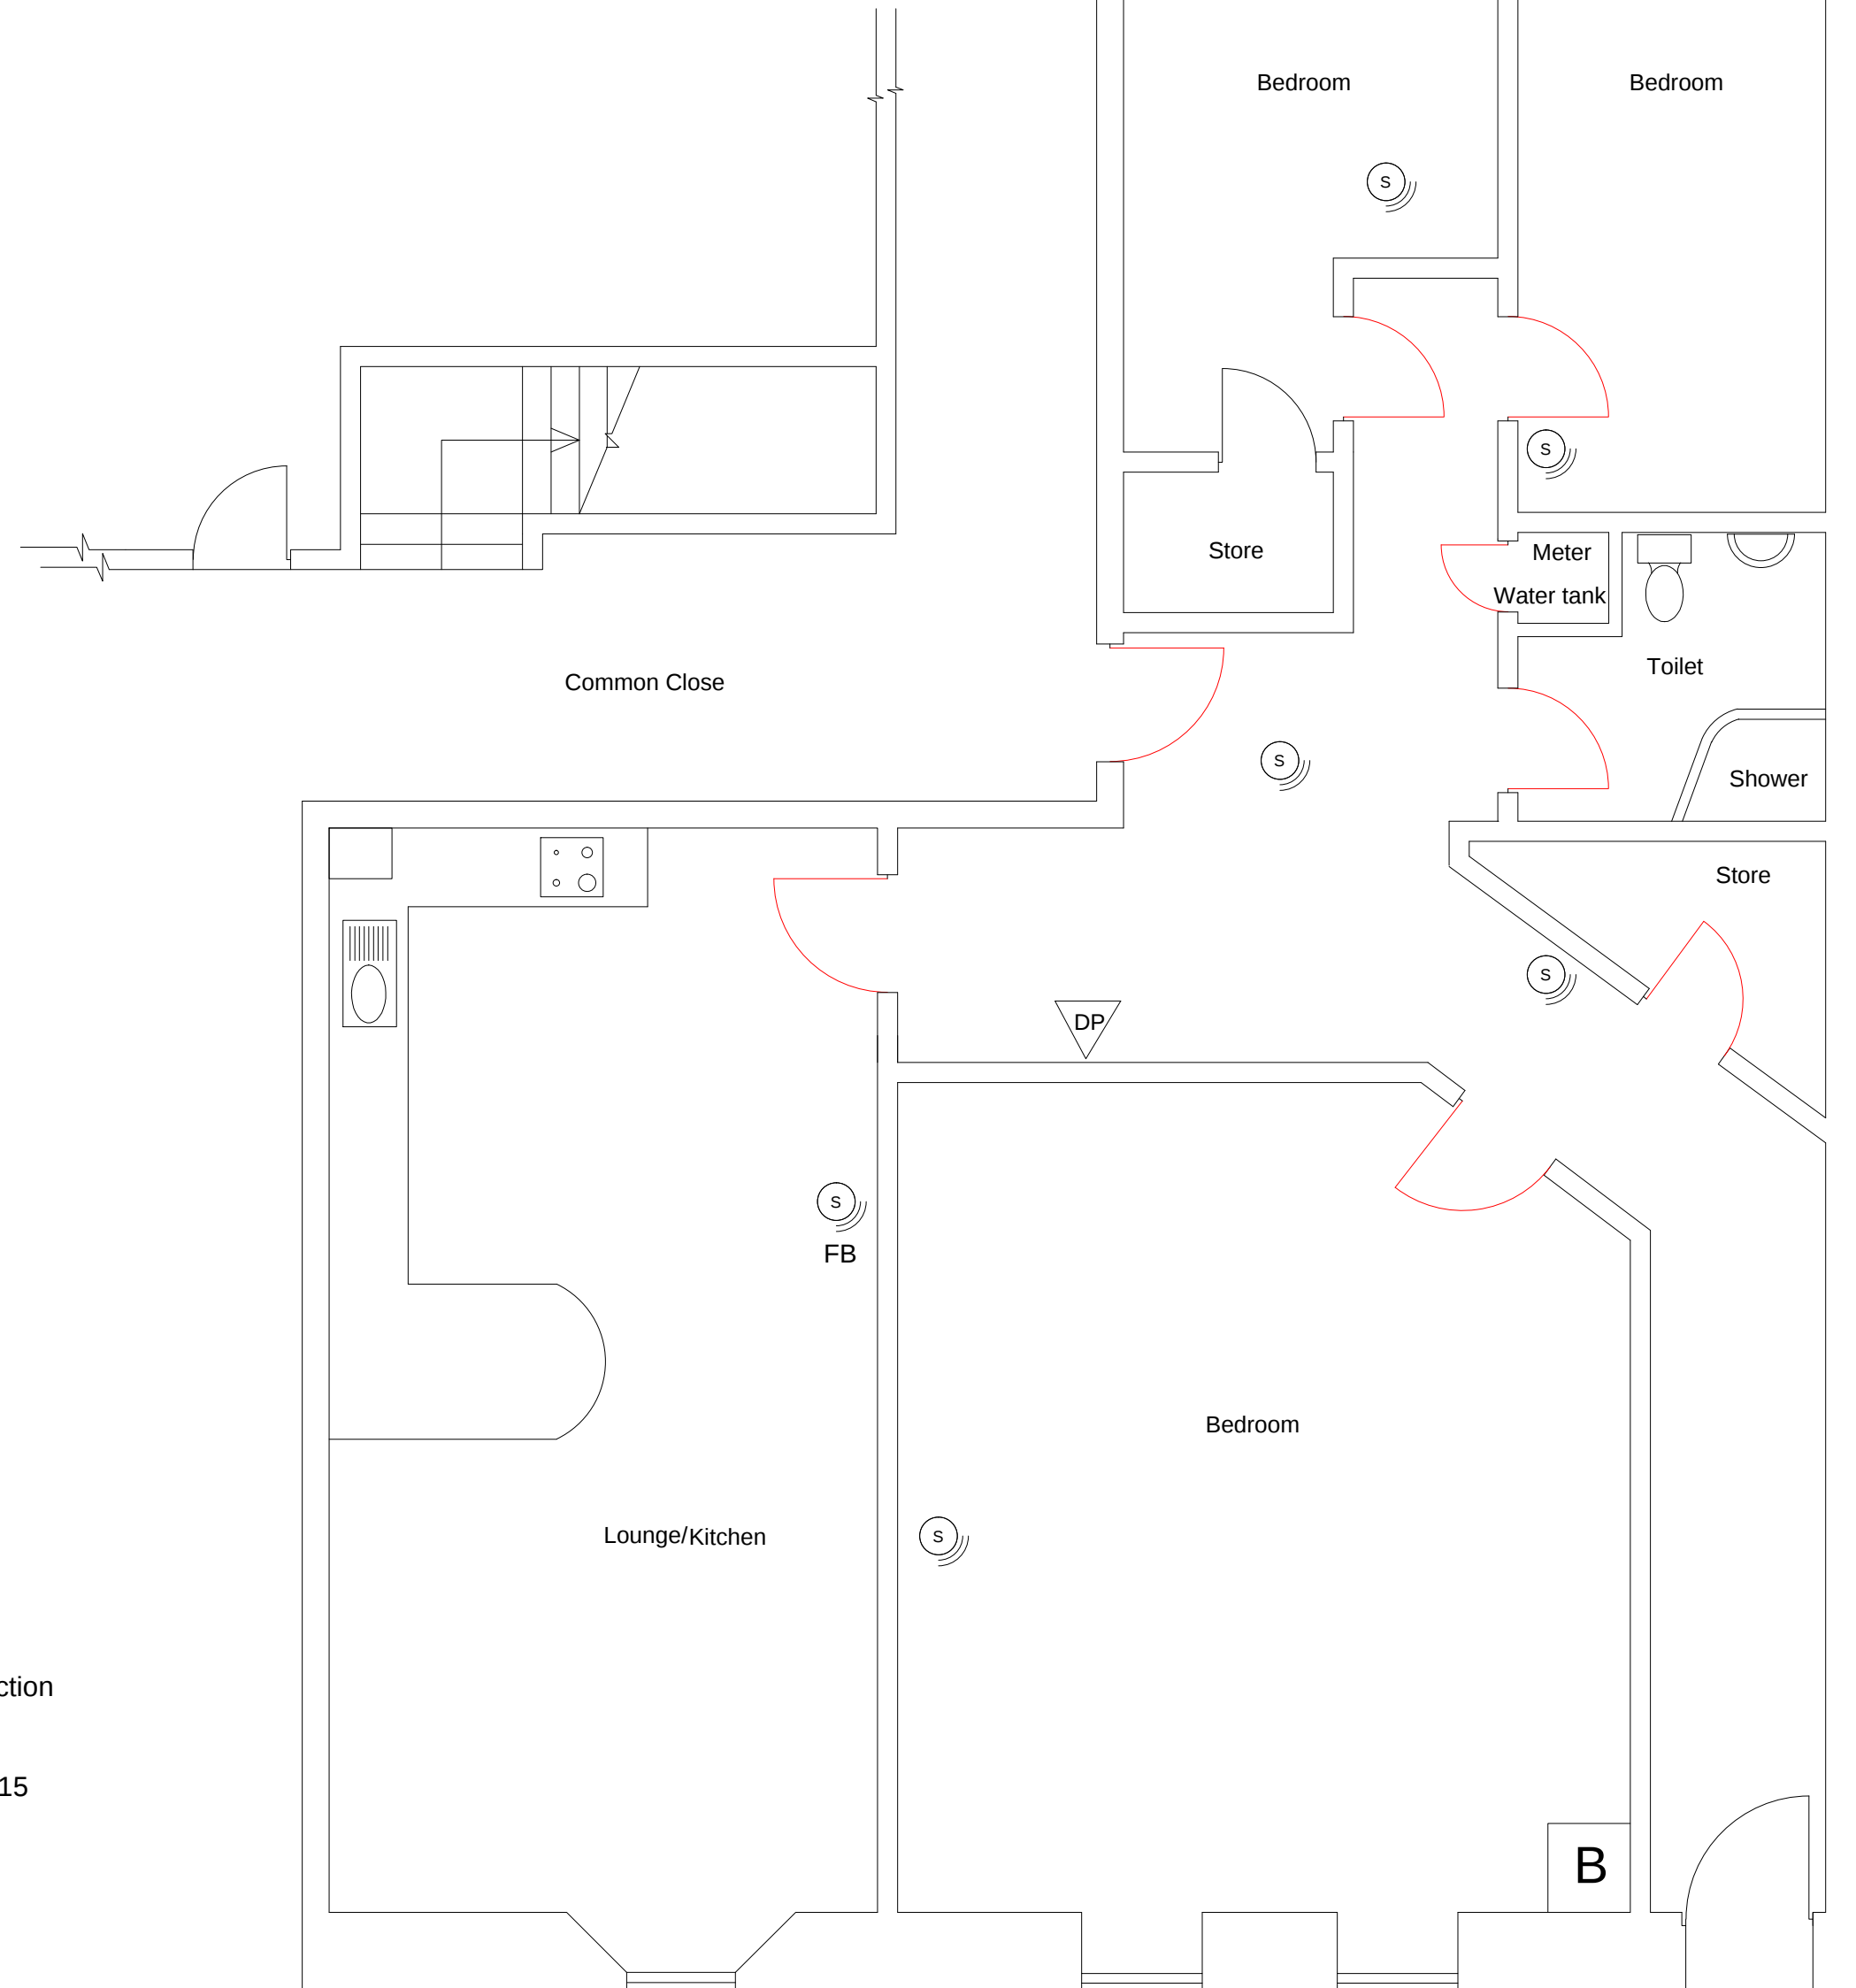


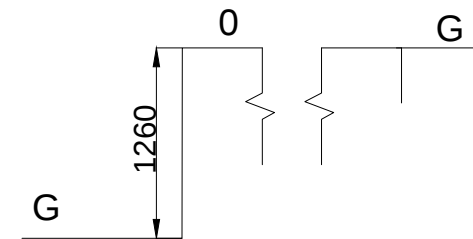

- Fire Door 
- Smoke detector with sounder 
- Dry Powder Extinguisher 
- Fire Blanket 
- Boiler 

Main Door
39 Kersland Street
Glasgow
G12 8BP

Drawing Floor Plan/Section
Drawing Number 39/G/01/01
Scale 1/50
Date 19 August, 2015

Group 3 Energy
28 Nelson Street
Kilmarnock
KA1 1BA
01563 529537

MD 39 Kersland Street